


**LEGEND**

- SITE BOUNDARY: Red solid line
- LAND OWNERSHIP BOUNDARY: Blue solid line
- PROPOSED BUILDING: Pink solid rectangle
- EXISTING BUILDING: Pink hatched rectangle
- MASTERPLAN AREA SUBJECT TO FUTURE DEVELOPMENT: Yellow hatched rectangle

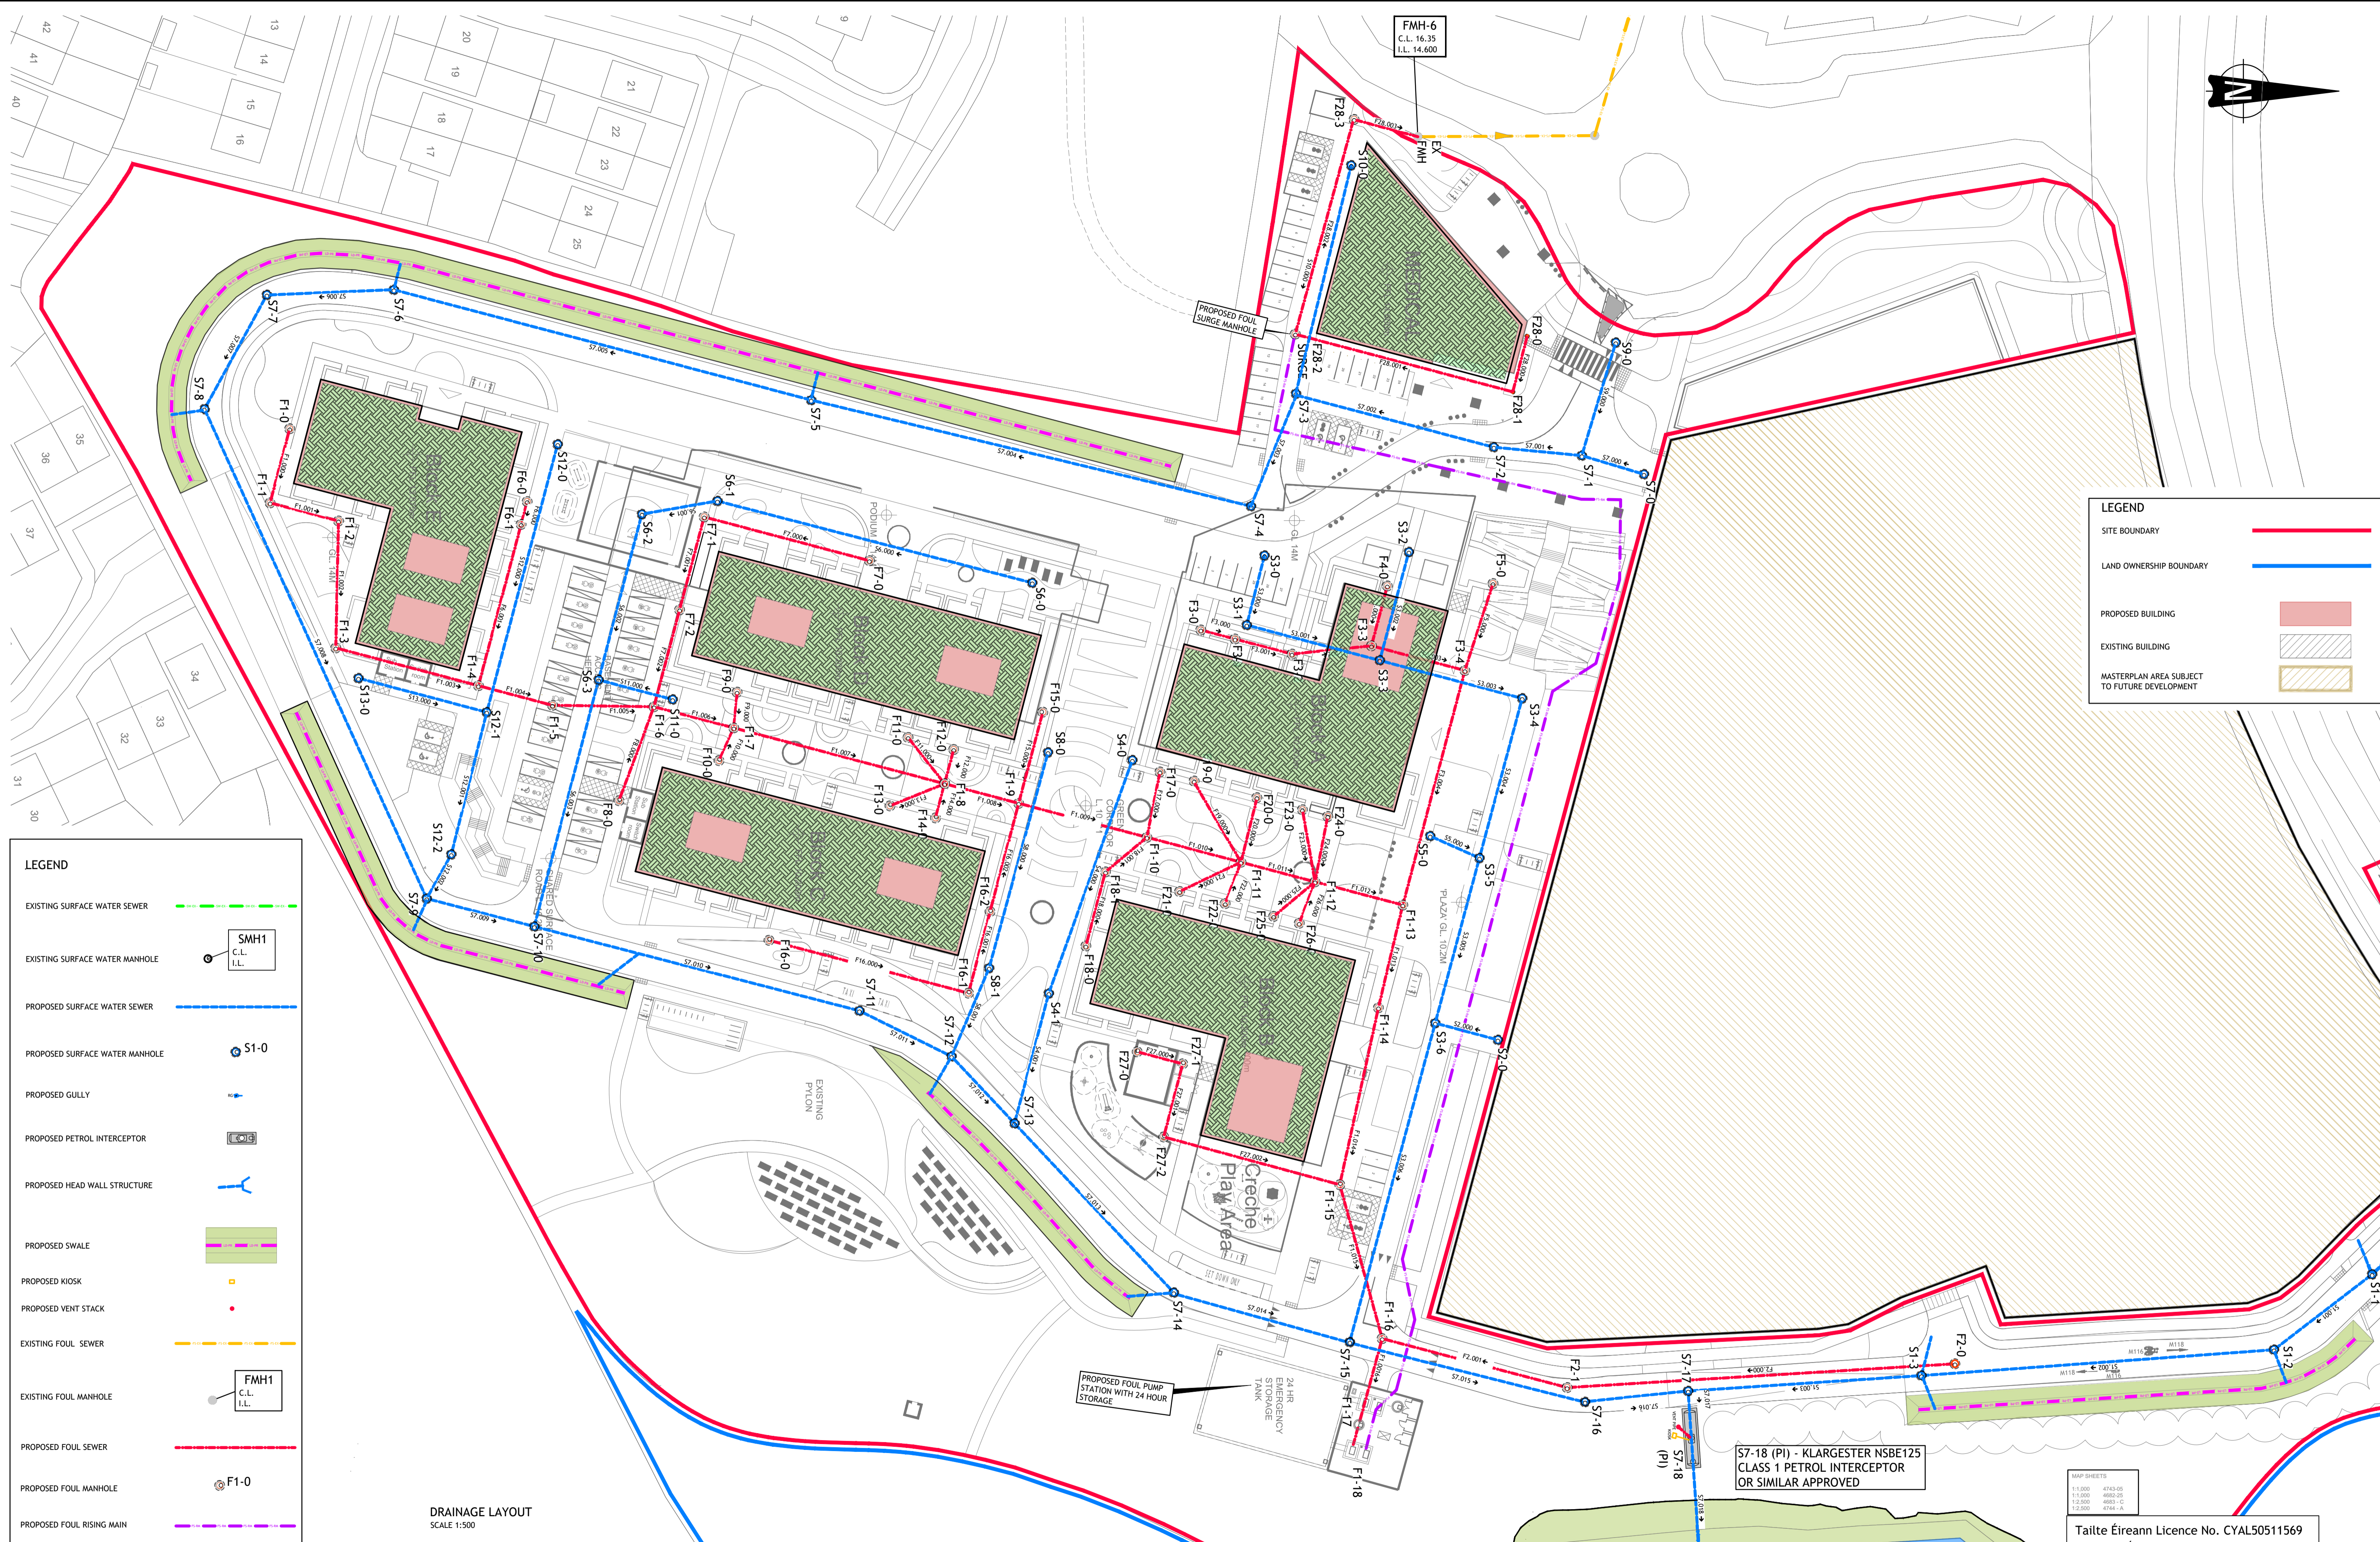

**LEGEND**

- EXISTING SURFACE WATER SEWER: Green dashed line
- EXISTING SURFACE WATER MANHOLE: Circle with 'SMH1' and 'C.L. I.L.' labels
- PROPOSED SURFACE WATER SEWER: Blue dashed line
- PROPOSED SURFACE WATER MANHOLE: Circle with 'S1-0' label
- PROPOSED GULLY: Blue arrow pointing down
- PROPOSED PETROL INTERCEPTOR: Rectangular symbol with 'PI' label
- PROPOSED HEAD WALL STRUCTURE: Blue Y-shaped symbol
- PROPOSED SWALE: Green dashed line with a central line
- PROPOSED KIOSK: Yellow square symbol
- PROPOSED VENT STACK: Red dot symbol
- EXISTING FOUL SEWER: Yellow dashed line
- EXISTING FOUL MANHOLE: Circle with 'FMH1' and 'C.L. I.L.' labels
- PROPOSED FOUL SEWER: Red dashed line
- PROPOSED FOUL MANHOLE: Circle with 'F1-0' label
- PROPOSED FOUL RISING MAIN: Purple dashed line

**DRAINAGE LAYOUT**  
SCALE 1:500

MAP SHEETS

1:1,000	4743-00
1:1,000	4802-25
1:2,000	4803-01
1:2,000	4744-01

Taitte Éireann Licence No. CYAL50511569  
© Taitte Éireann - Surveying.

© PUNCH Consulting Engineers  
This drawing and any design hereon is the copyright of the Consultants and must not be reproduced without their written consent. All drawings remain the property of the Consultants. Figured dimension only to be taken from this drawing. Consultants to be informed immediately of any discrepancies before work proceeds.

ISO 9001 QUALITY MANAGEMENT	ISO 14001 ENVIRONMENTAL MANAGEMENT	ISO 45001 HEALTH & SAFETY MANAGEMENT	NSAI Certified

Rev	Amendment	By	Date
CO1	ISSUED FOR PLANNING	SK	2026-05-15

Rev	Amendment	By	Date	Client

**PUNCH**  
CONSULTING ENGINEERS  
Dublin | Limerick | Cork | Galway | Glasgow | Macleodfield  
97 Henry Street, Limerick, V94 YC2H, Ireland  
t+353 61 221 200 | w.punchconsulting.com

Project:	PARKWAY VALLEY LRD		
Title:	PROPOSED DRAINAGE LAYOUT - SHEET 1		
Drawn:	PJ Mulcahy	2025-09-23	2025-09-23
Project No:	231171	231171-PUNCH-XX-XX-M2-C-0101-0102	AO (PLANNING)
Scale @ A3:	1500	231171-PUNCH-XX-XX-DR-C-0101	CO1